

## Clinch Mountain Ry.

HO scale (1:87.1)

Layout size: 10 x 13 feet

Scale of plan: 3/8" = 1'-0", 24" grid

Numbered arrows indicate photo locations


Illustration by Rick Johnson

Find more plans online in the  
ModelRailroader.com Track Plan Database.

### Original layout room

© 2014 Kalmbach Publishing Co.,  
Model Railroader magazine.  
This material may not be reproduced  
in any form without permission  
from the publisher.  
[www.ModelRailroader.com](http://www.ModelRailroader.com)



To original layout ↑↑

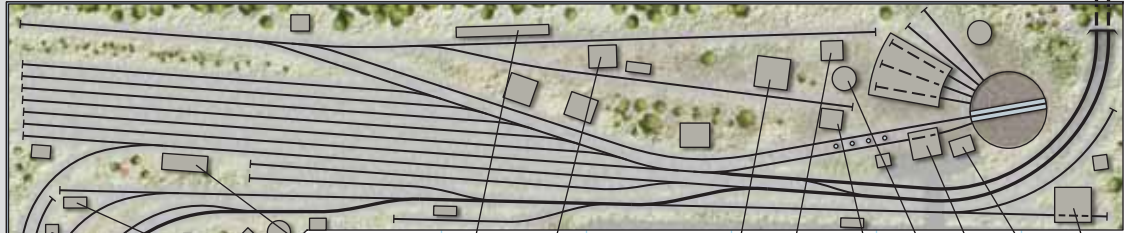

Station  
Garage  
REA office  
Iron foundry  
Dairy  
REA warehouse  
Icing platform  
Propane distributor  
**Marysville**  
Tool and die company  
Water  
Coal  
Sand  
Cement plant

**New section**

HO scale (1:87.1)  
Layout size: 10 x 20 feet

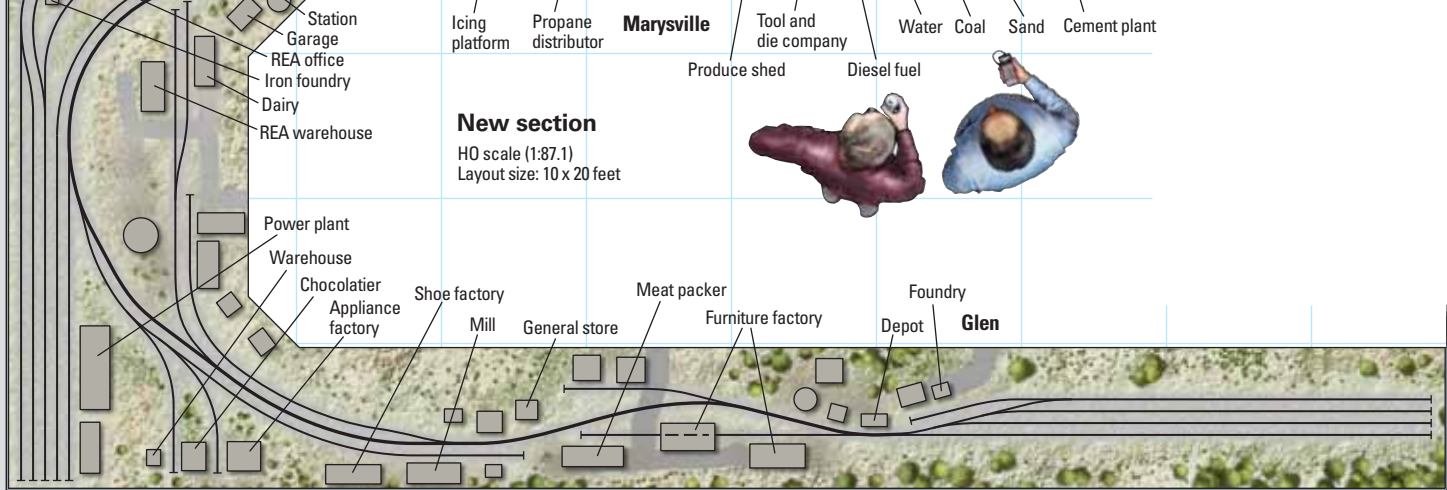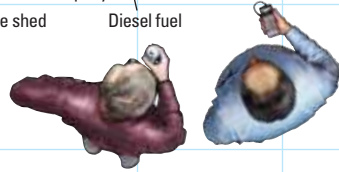

Power plant  
Warehouse  
Chocolatier  
Appliance factory  
Shoe factory  
Mill  
General store  
Meat packer  
Furniture factory  
Depot  
Foundry  
**Glen**