

GOTHAM COUNTY (still in planning)

UPPER GOTHAM

County line

GOTHAM CITY


Back Street

Downtown Terminal

EAST GOTHAM

Industry Drive

Erie RR viaduct

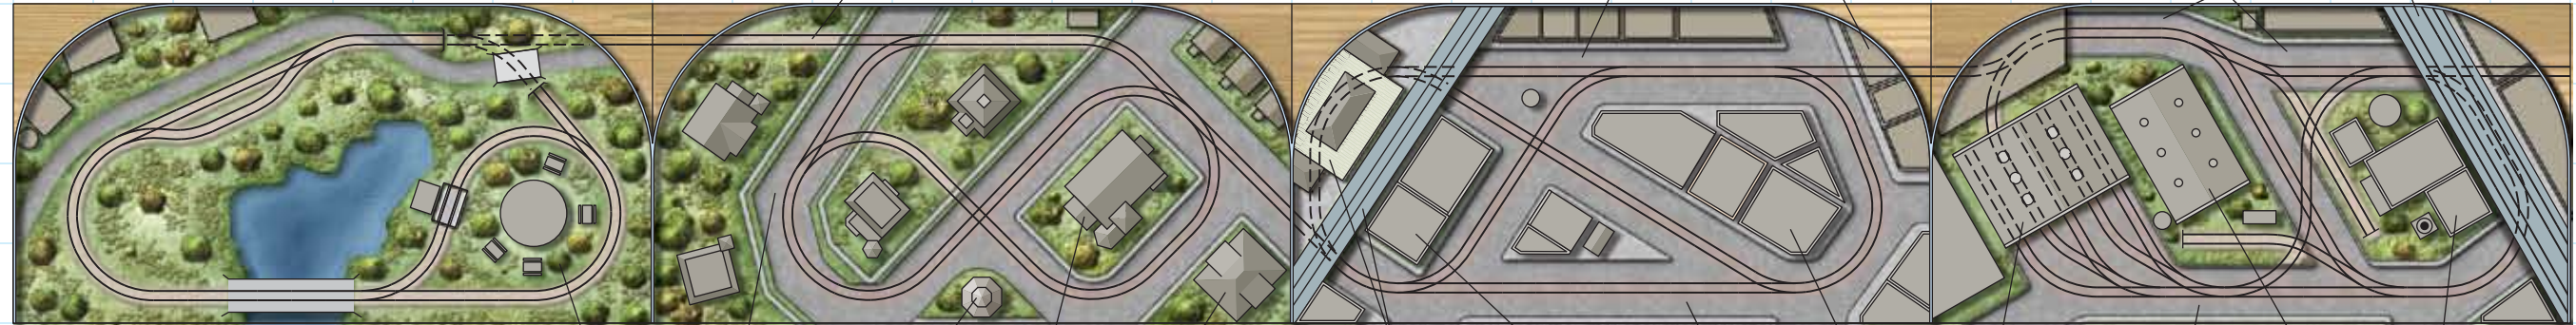

TOWN & COUNTRY TRACTION CO.

Scale: 7/8" = 1'-0"
6" grid

Park

Mansion Avenue

Bandstand

Church

School

Elevated tracks and depot

Fire Department

Front Street

First National Bank

T&TCT carbarn

Traction Avenue

Power Plant

Factory

© 2002 Kalmbach Publishing Co., Model Railroader